

# ARCHITECTURAL MANUFACTURING SCIENCES

**GENERAL NOTES:**

-SECOND FLOOR JOISTS  
WESTERN WOODS #2 @ 16" O.C.




-FOUNDATION VENTS 8" X  
16" @ 10'-0" O.C.

-ALL FOUNDATION WALLS  
DIMENSIONED TO FACE OF  
CMU

- ALL PIERS DIMENSIONED  
TO CENTER OF PIER

-LAP ALL BOARDS IN MEAN  
CONSTRUCTION 4'-0" MIN.

DOUBLE ALL FLOOR JOISTS  
UNDER PARALLEL WALLS AND  
PLUMBING FIXTURES

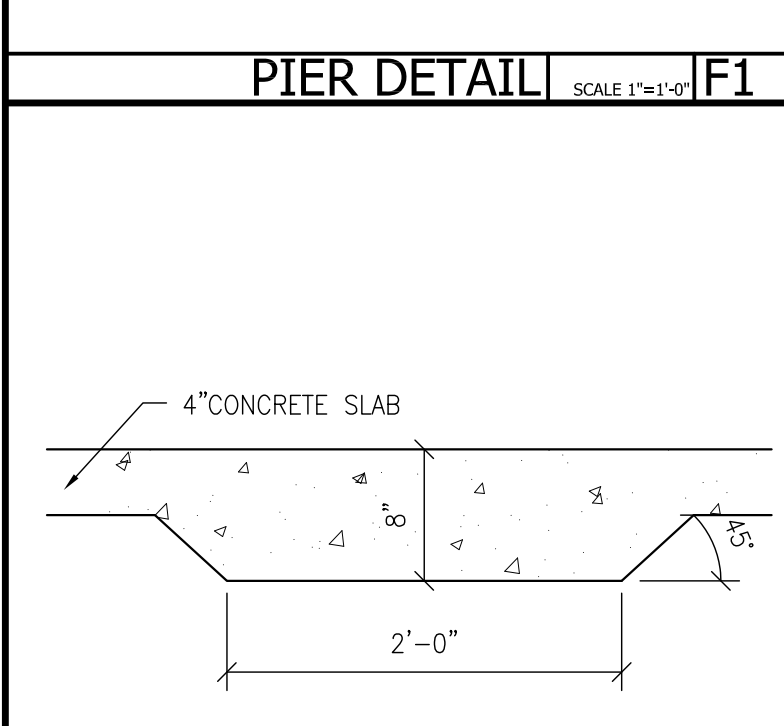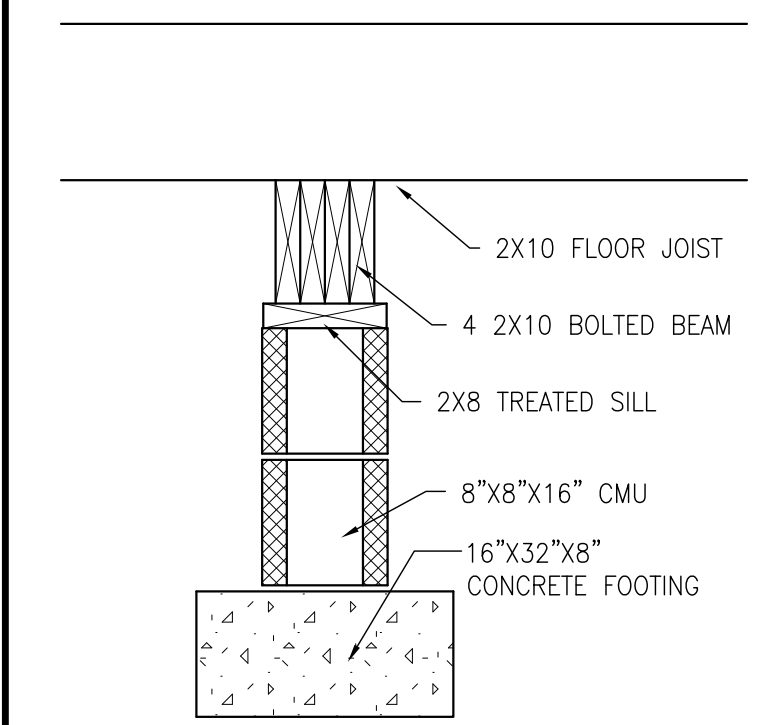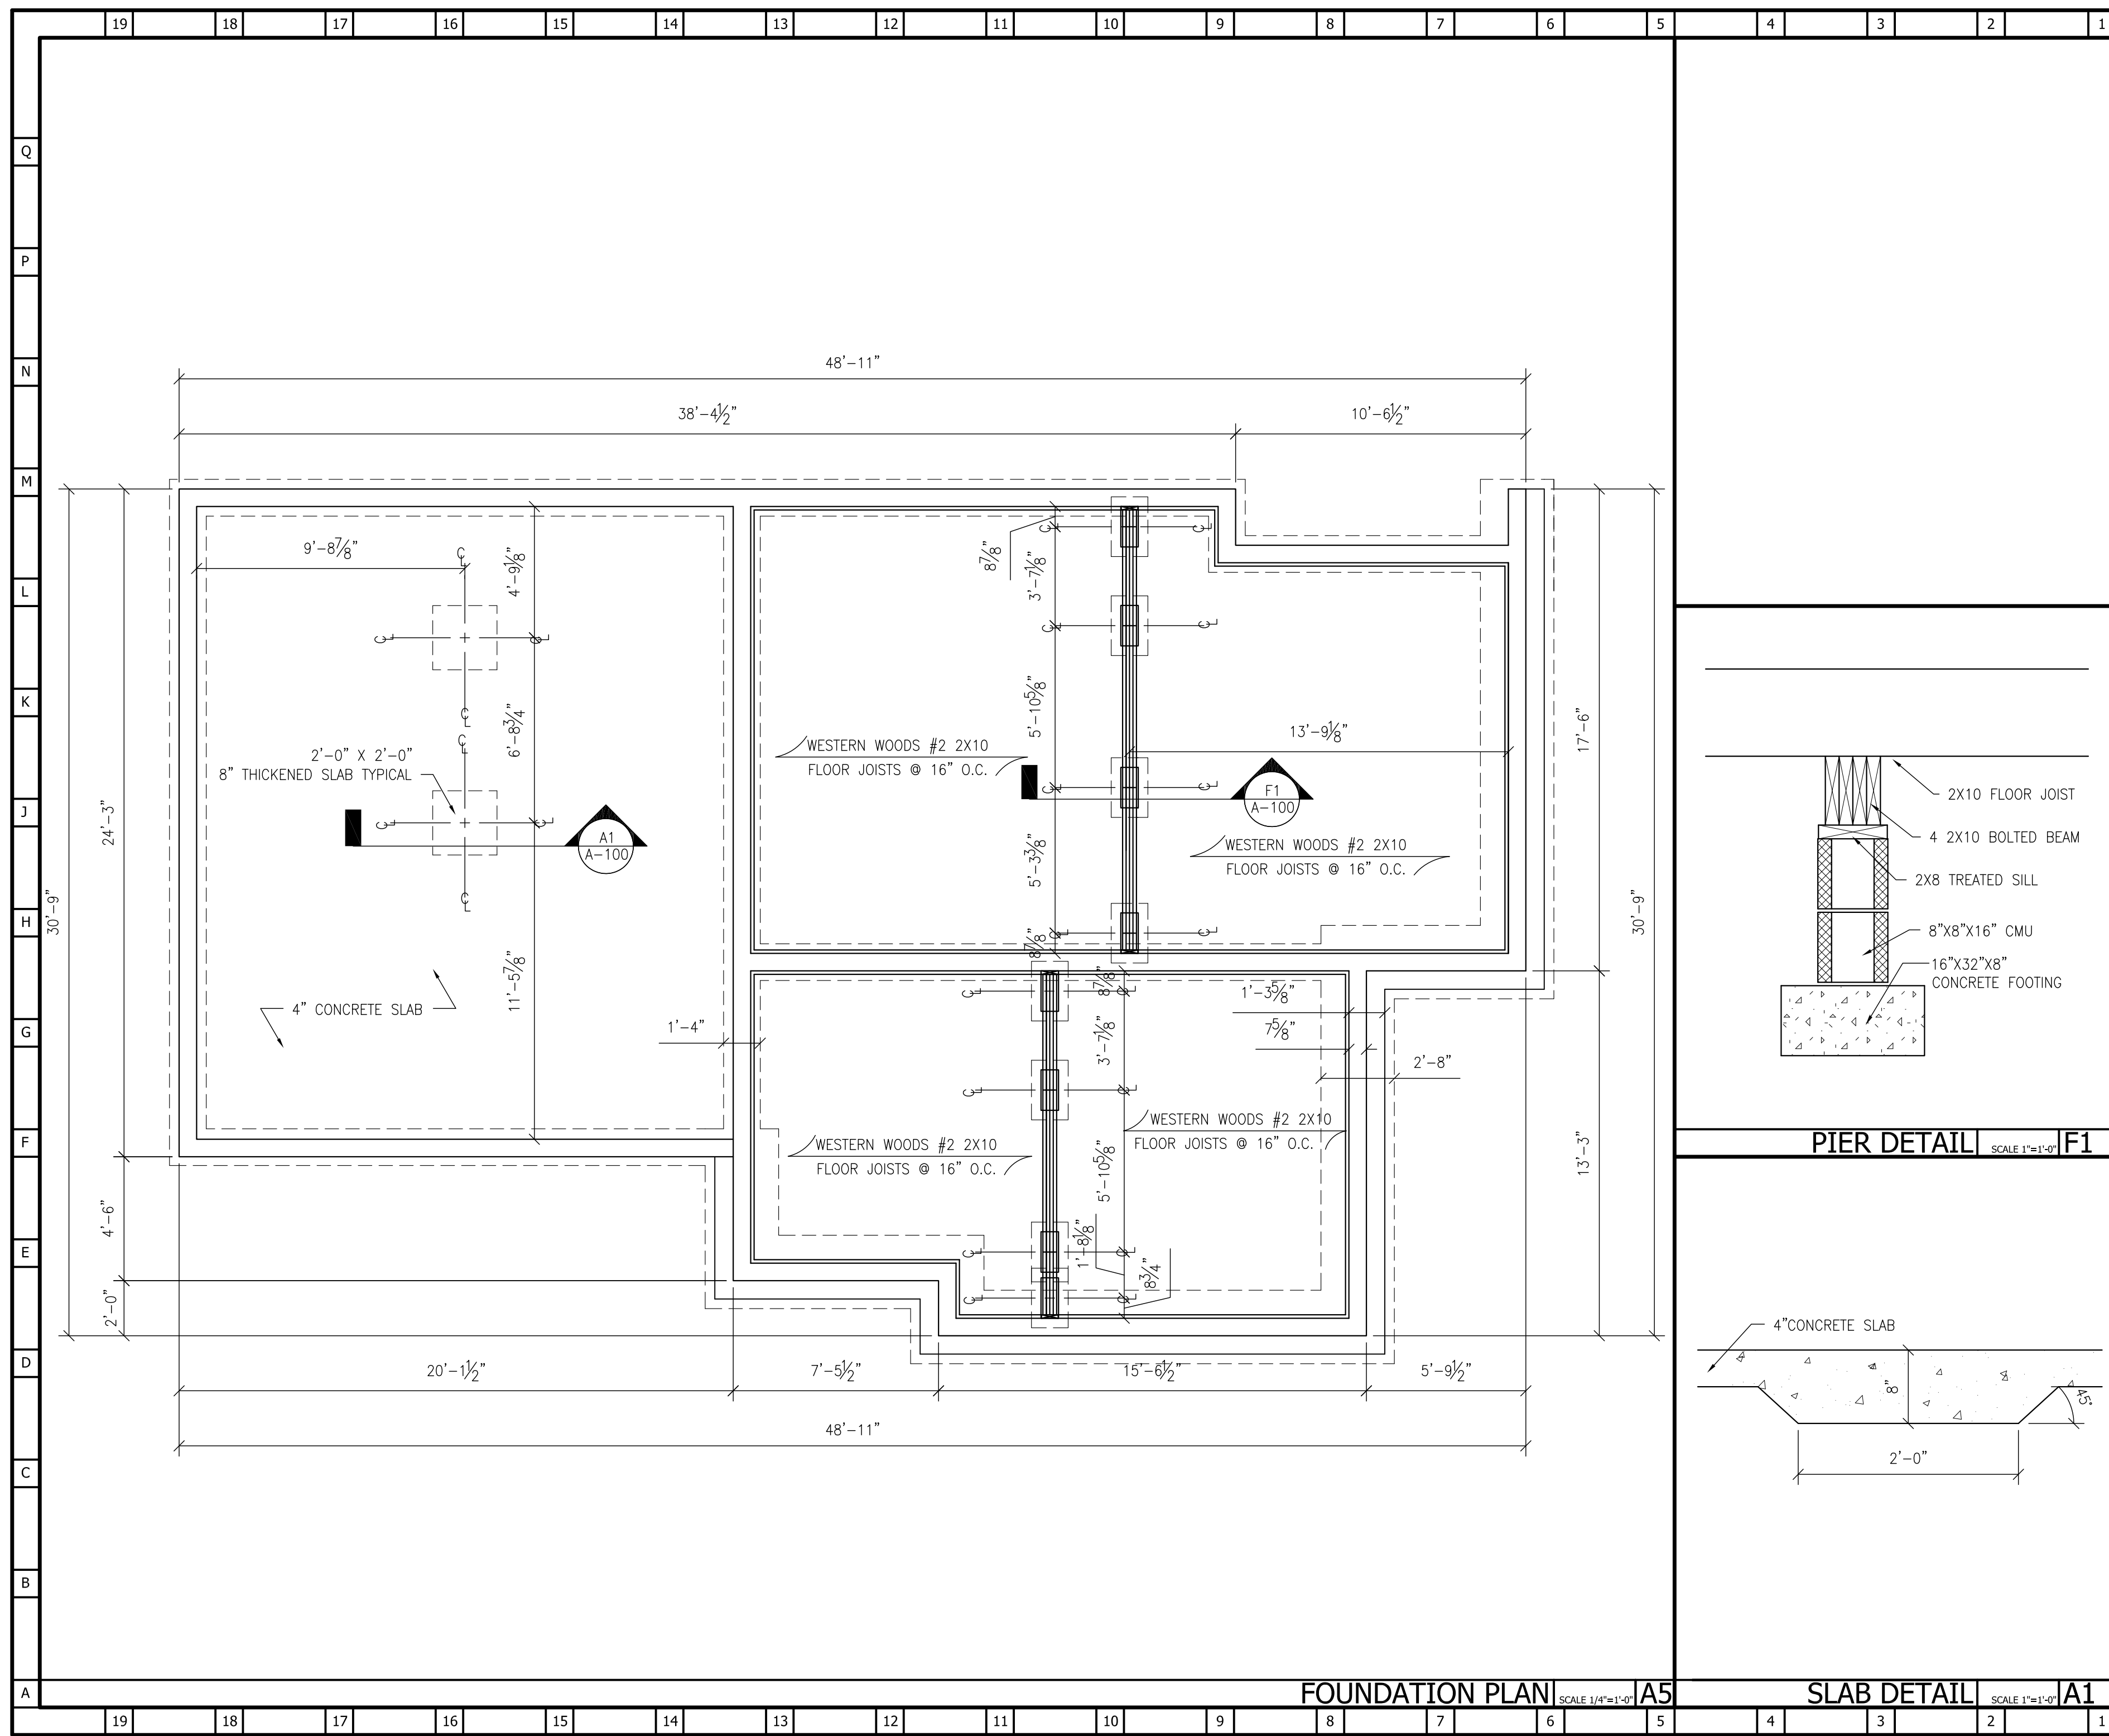

**PIER DETAIL** SCALE 1"=1'-0" **F1**

**SLAB DETAIL** SCALE 1"=1'-0" **A1**

**FOUNDATION PLAN** SCALE 1/4"=1'-0" **A5**

REVISION DESCRIPTION	DATE	REVISION DESCRIPTION	DATE
REDLINE CORRECTIONS	11/27/06	REDLINE CORRECTIONS	11/27/06
GENERAL NOTES FIX	12/04/06	GENERAL NOTES FIX	12/04/06

**STUDENT:**  
KEVIN BARTHLOW

**CLASS:**  
AMS320-002


**DATE:** 11/06/06

**SCALE:** AS INDICATED

**PROJECT:**  
JONES HOUSE

**FOUNDATION PLAN AND DETAILS**

## A-100

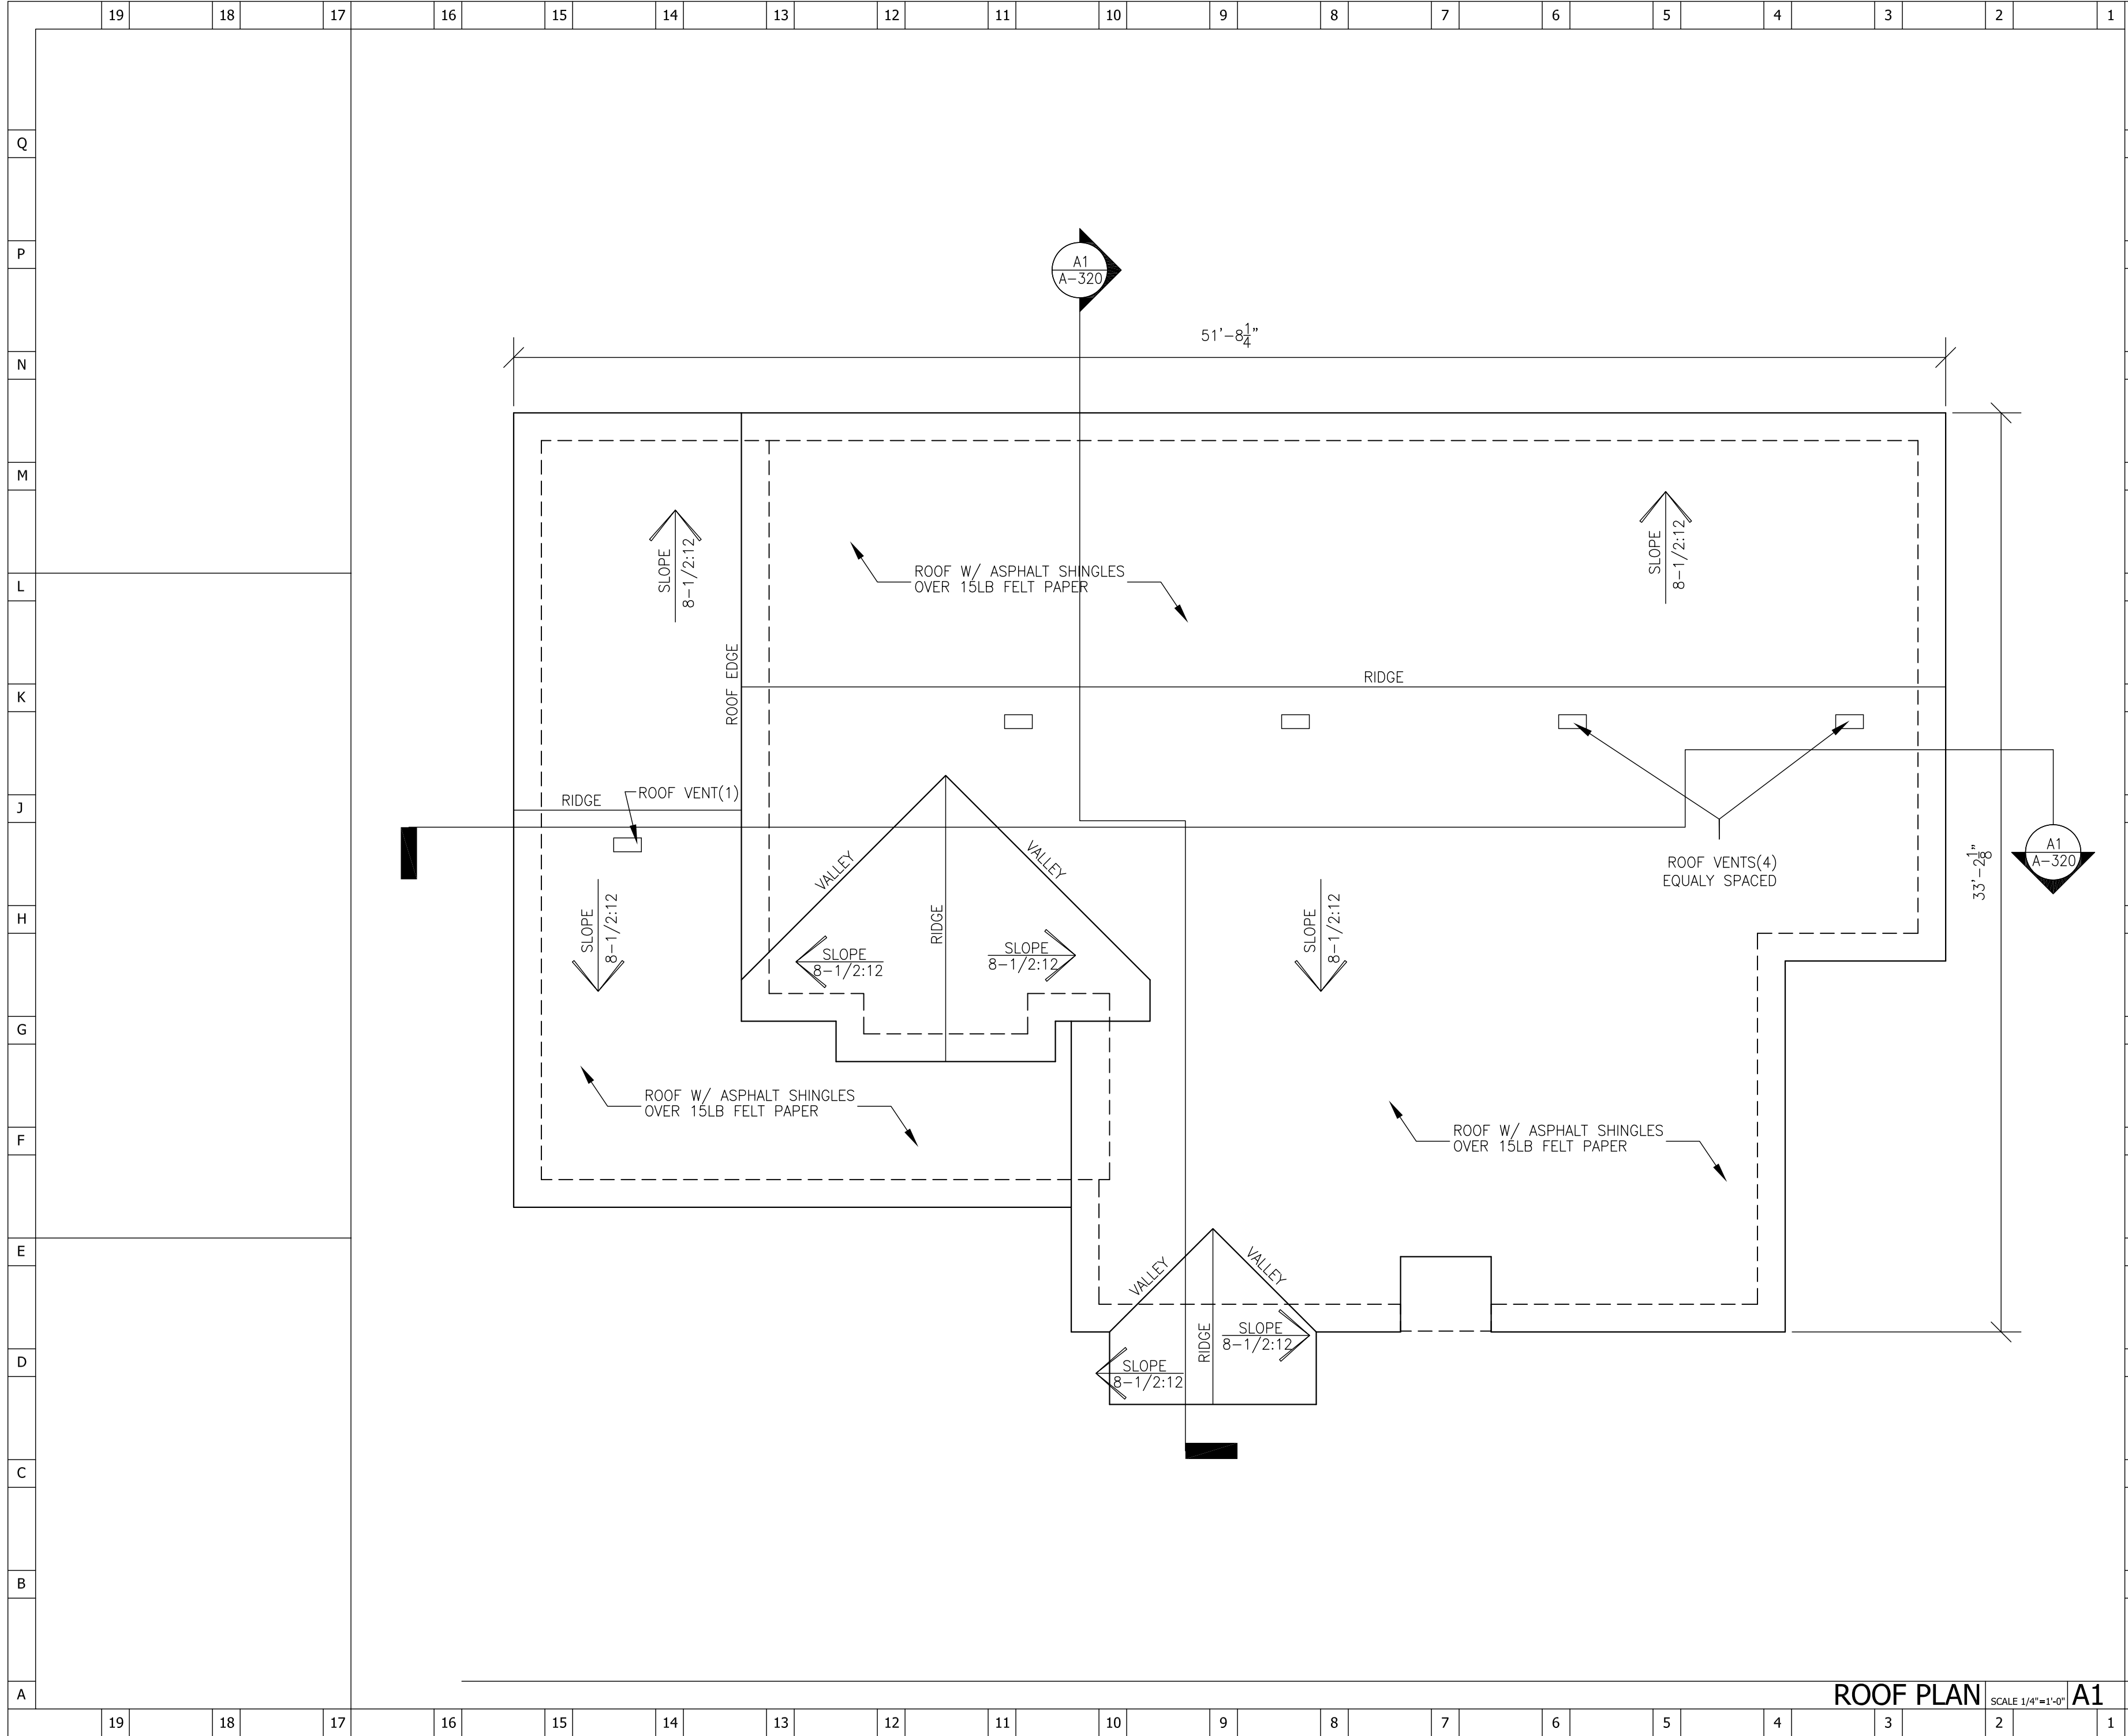

REVISION DESCRIPTION	DATE	#
		1
		2
		3
		4
		5
		6
		7

STUDENT:  
KEVIN BARTHLOW

CLASS:  
AMS-320-02

DATE: 11-10-06

SCALE: AS INDICATED


PROJECT:  
JONES HOUSE  
ROOF PLAN

ROOF PLAN SCALE 1/4"=1'-0" A1

**A-110**



SECOND FLOOR SECTION SCALE 1/16"=1'-0" G1

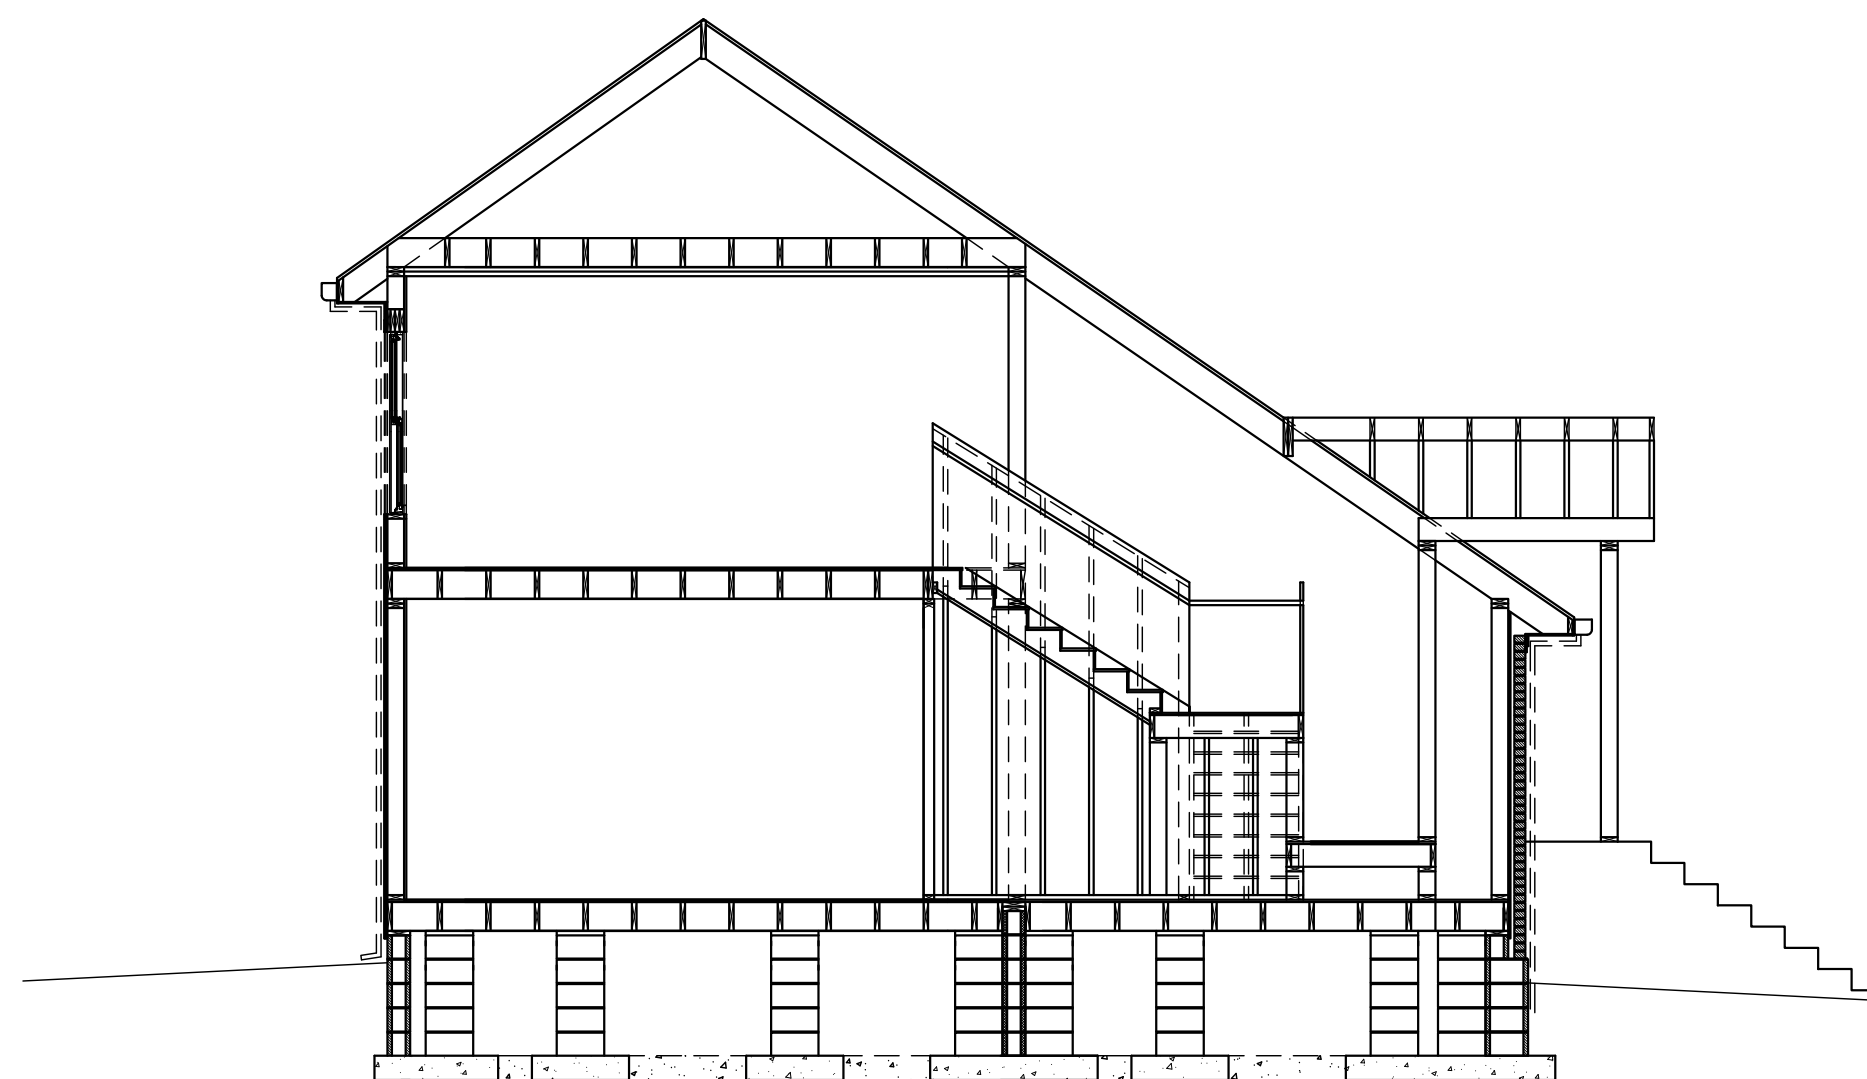

FIRST FLOOR SECTION SCALE 1/16"=1'-0" A1

REVISION DESCRIPTION	DATE:	#	1	2	3	4	5	6	7

STUDENT:  
KEVIN BARTHLOW

CLASS:  
AMS-320-002


DATE: 10/04/06

SCALE: AS INDICATED


PROJECT:  
JONES HOUSE

BUILDING SECTION


**A-300**

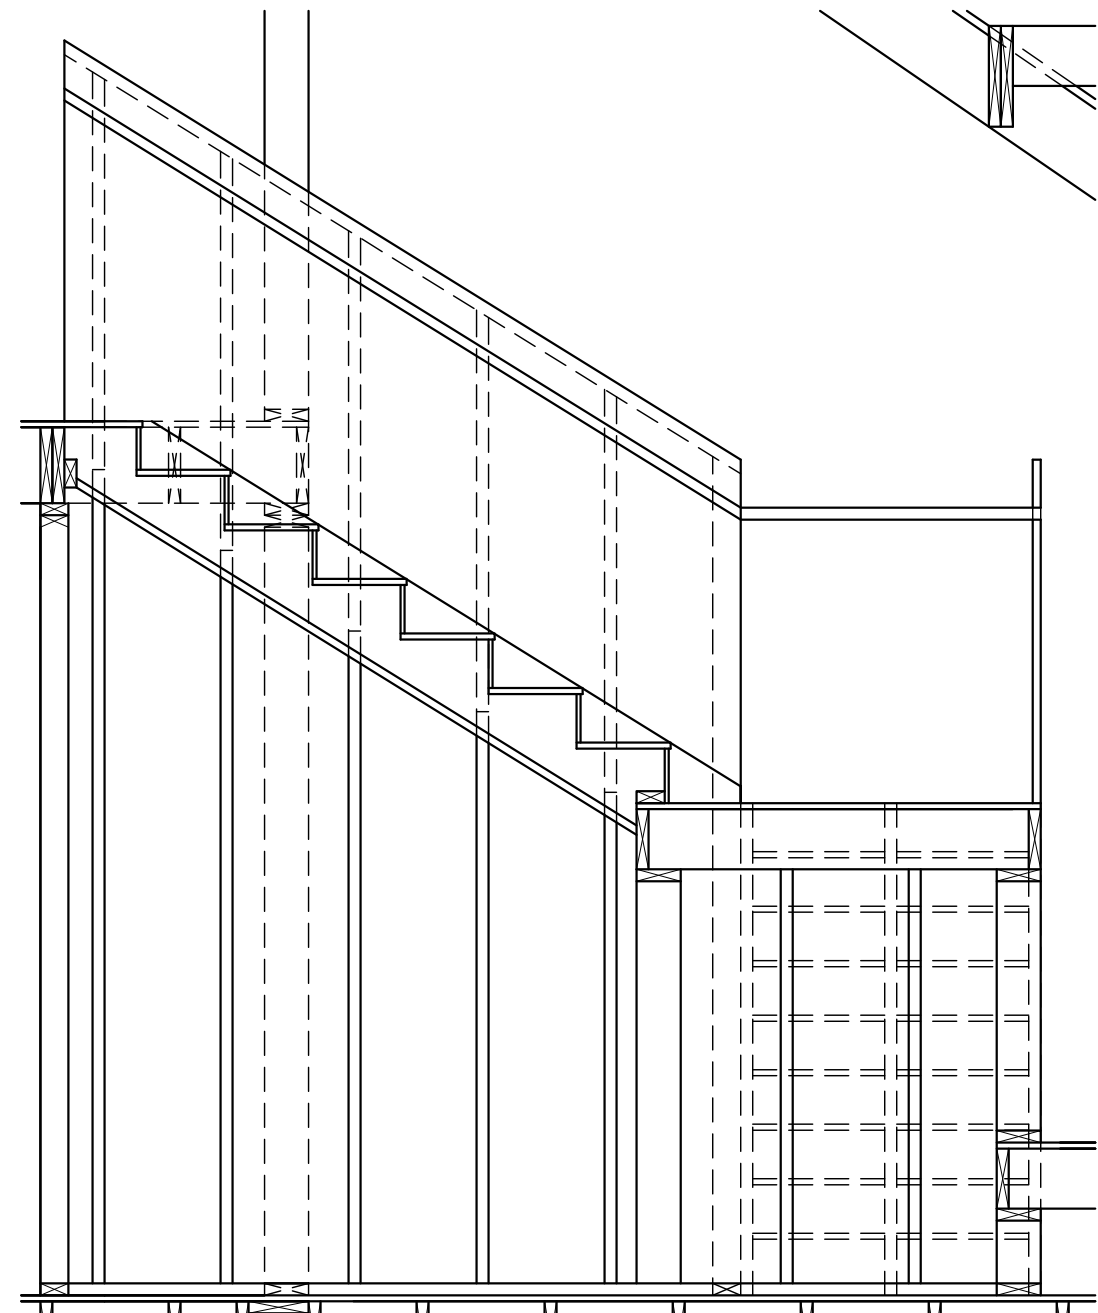


STAIR SECTION SCALE 1/2"=1'-0" H8

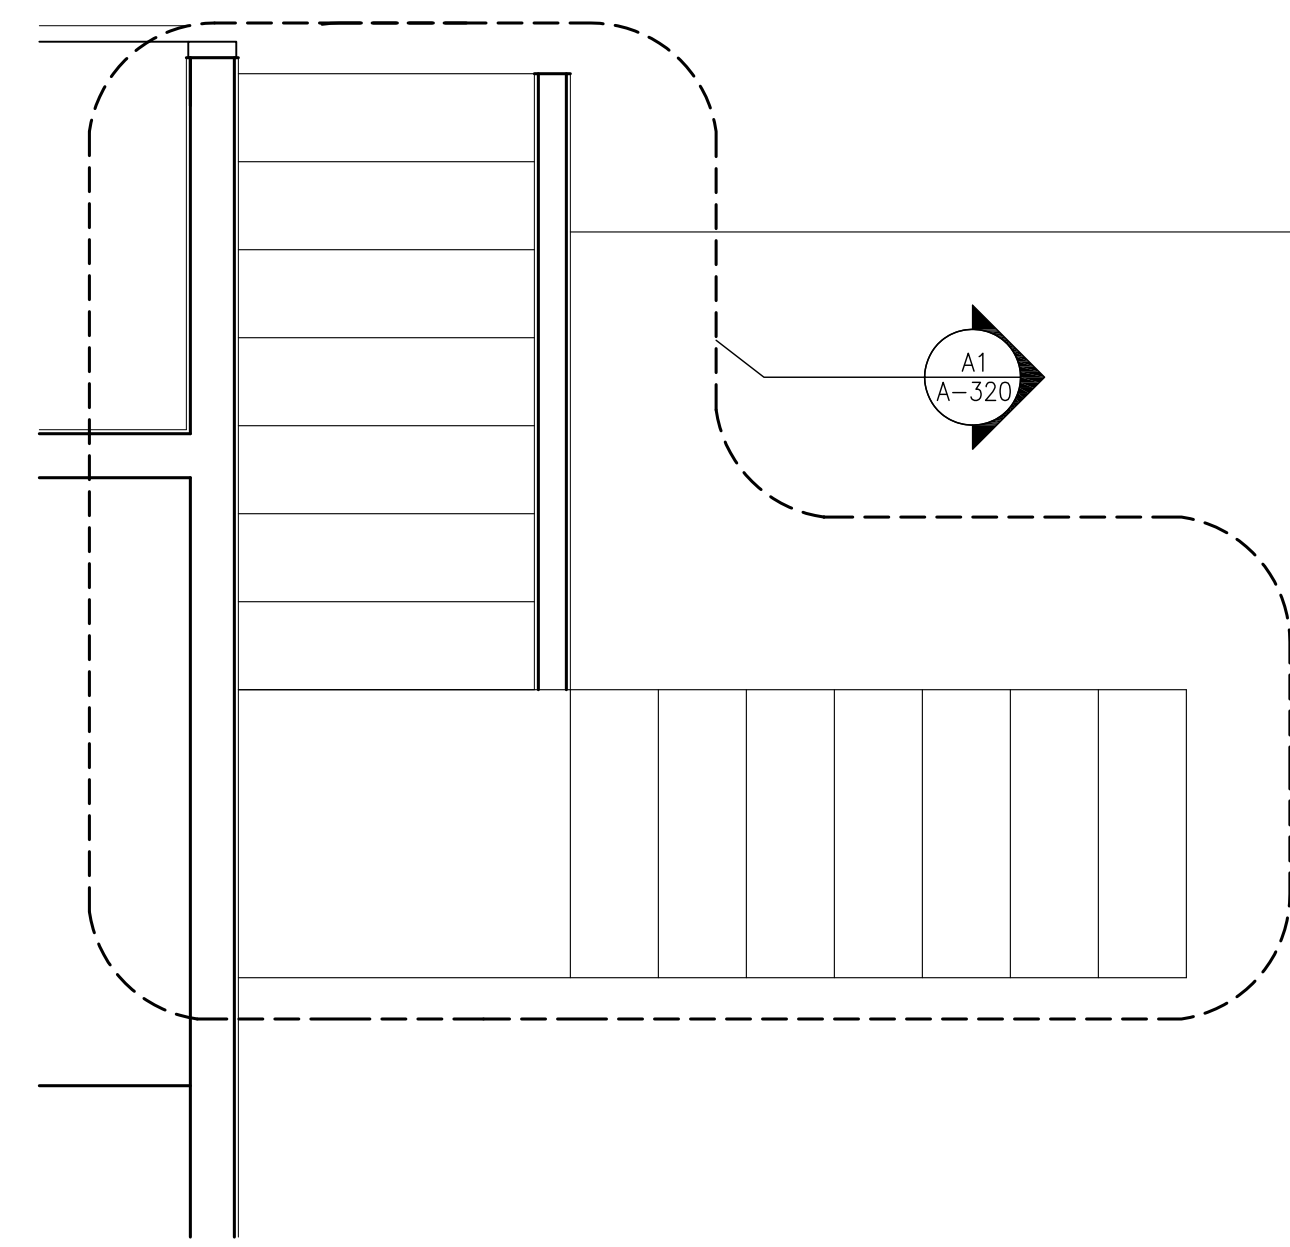

STAIR PLAN 'B' SECOND FLOOR SCALE 1/2"=1'-0" H1

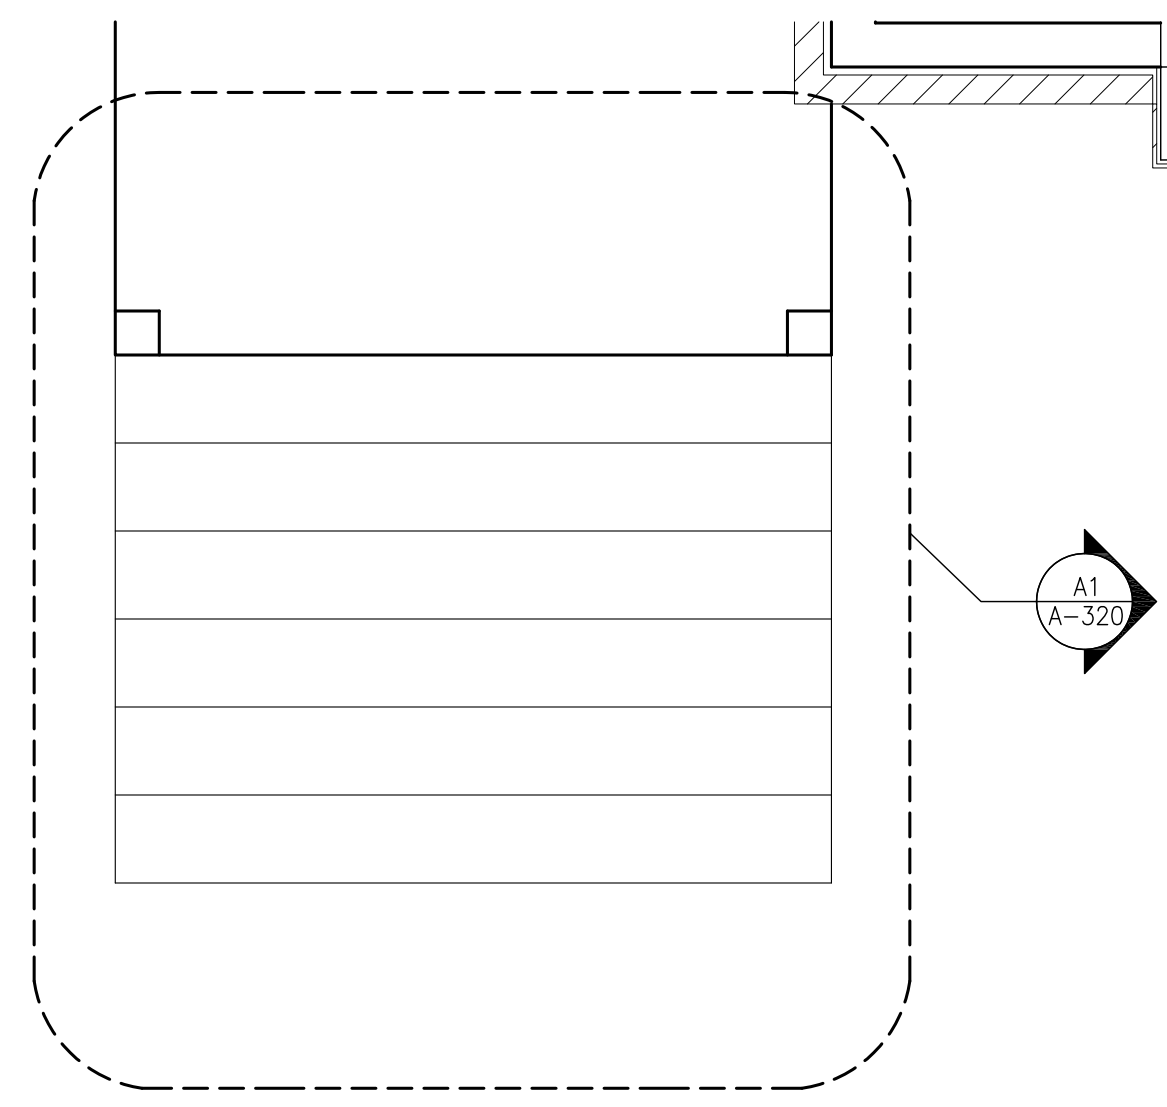

STAIR PLAN 'C' FIRST FLOOR SCALE 1/2"=1'-0" A8

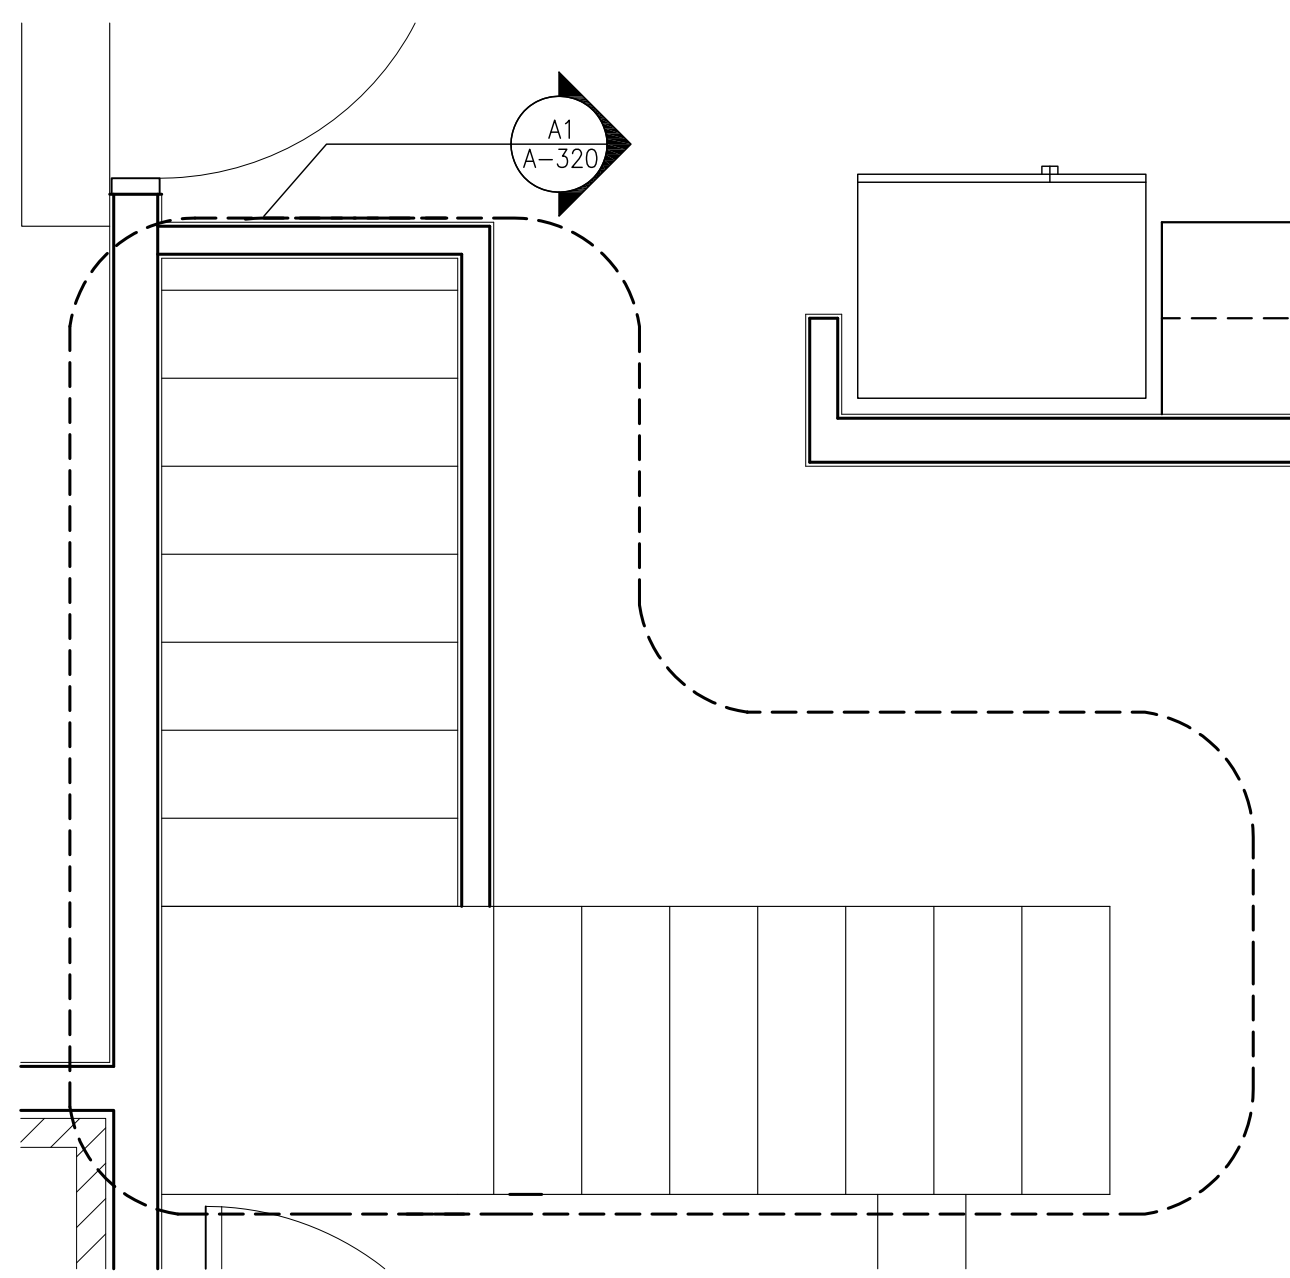

STAIR PLAN 'A' FIRST FLOOR SCALE 1/2"=1'-0" A1

REVISION DESCRIPTION	
DATE:	
#	
1	
2	
3	
4	
5	
6	
7	

STUDENT:  
KEVIN BARTHLOW


CLASS:  
AMS 320-02

DATE: 10-18-06

SCALE: AS INDICATED

PROJECT:  
JONES HOUSE  
VERTICAL CIRCULATION

**A-320**

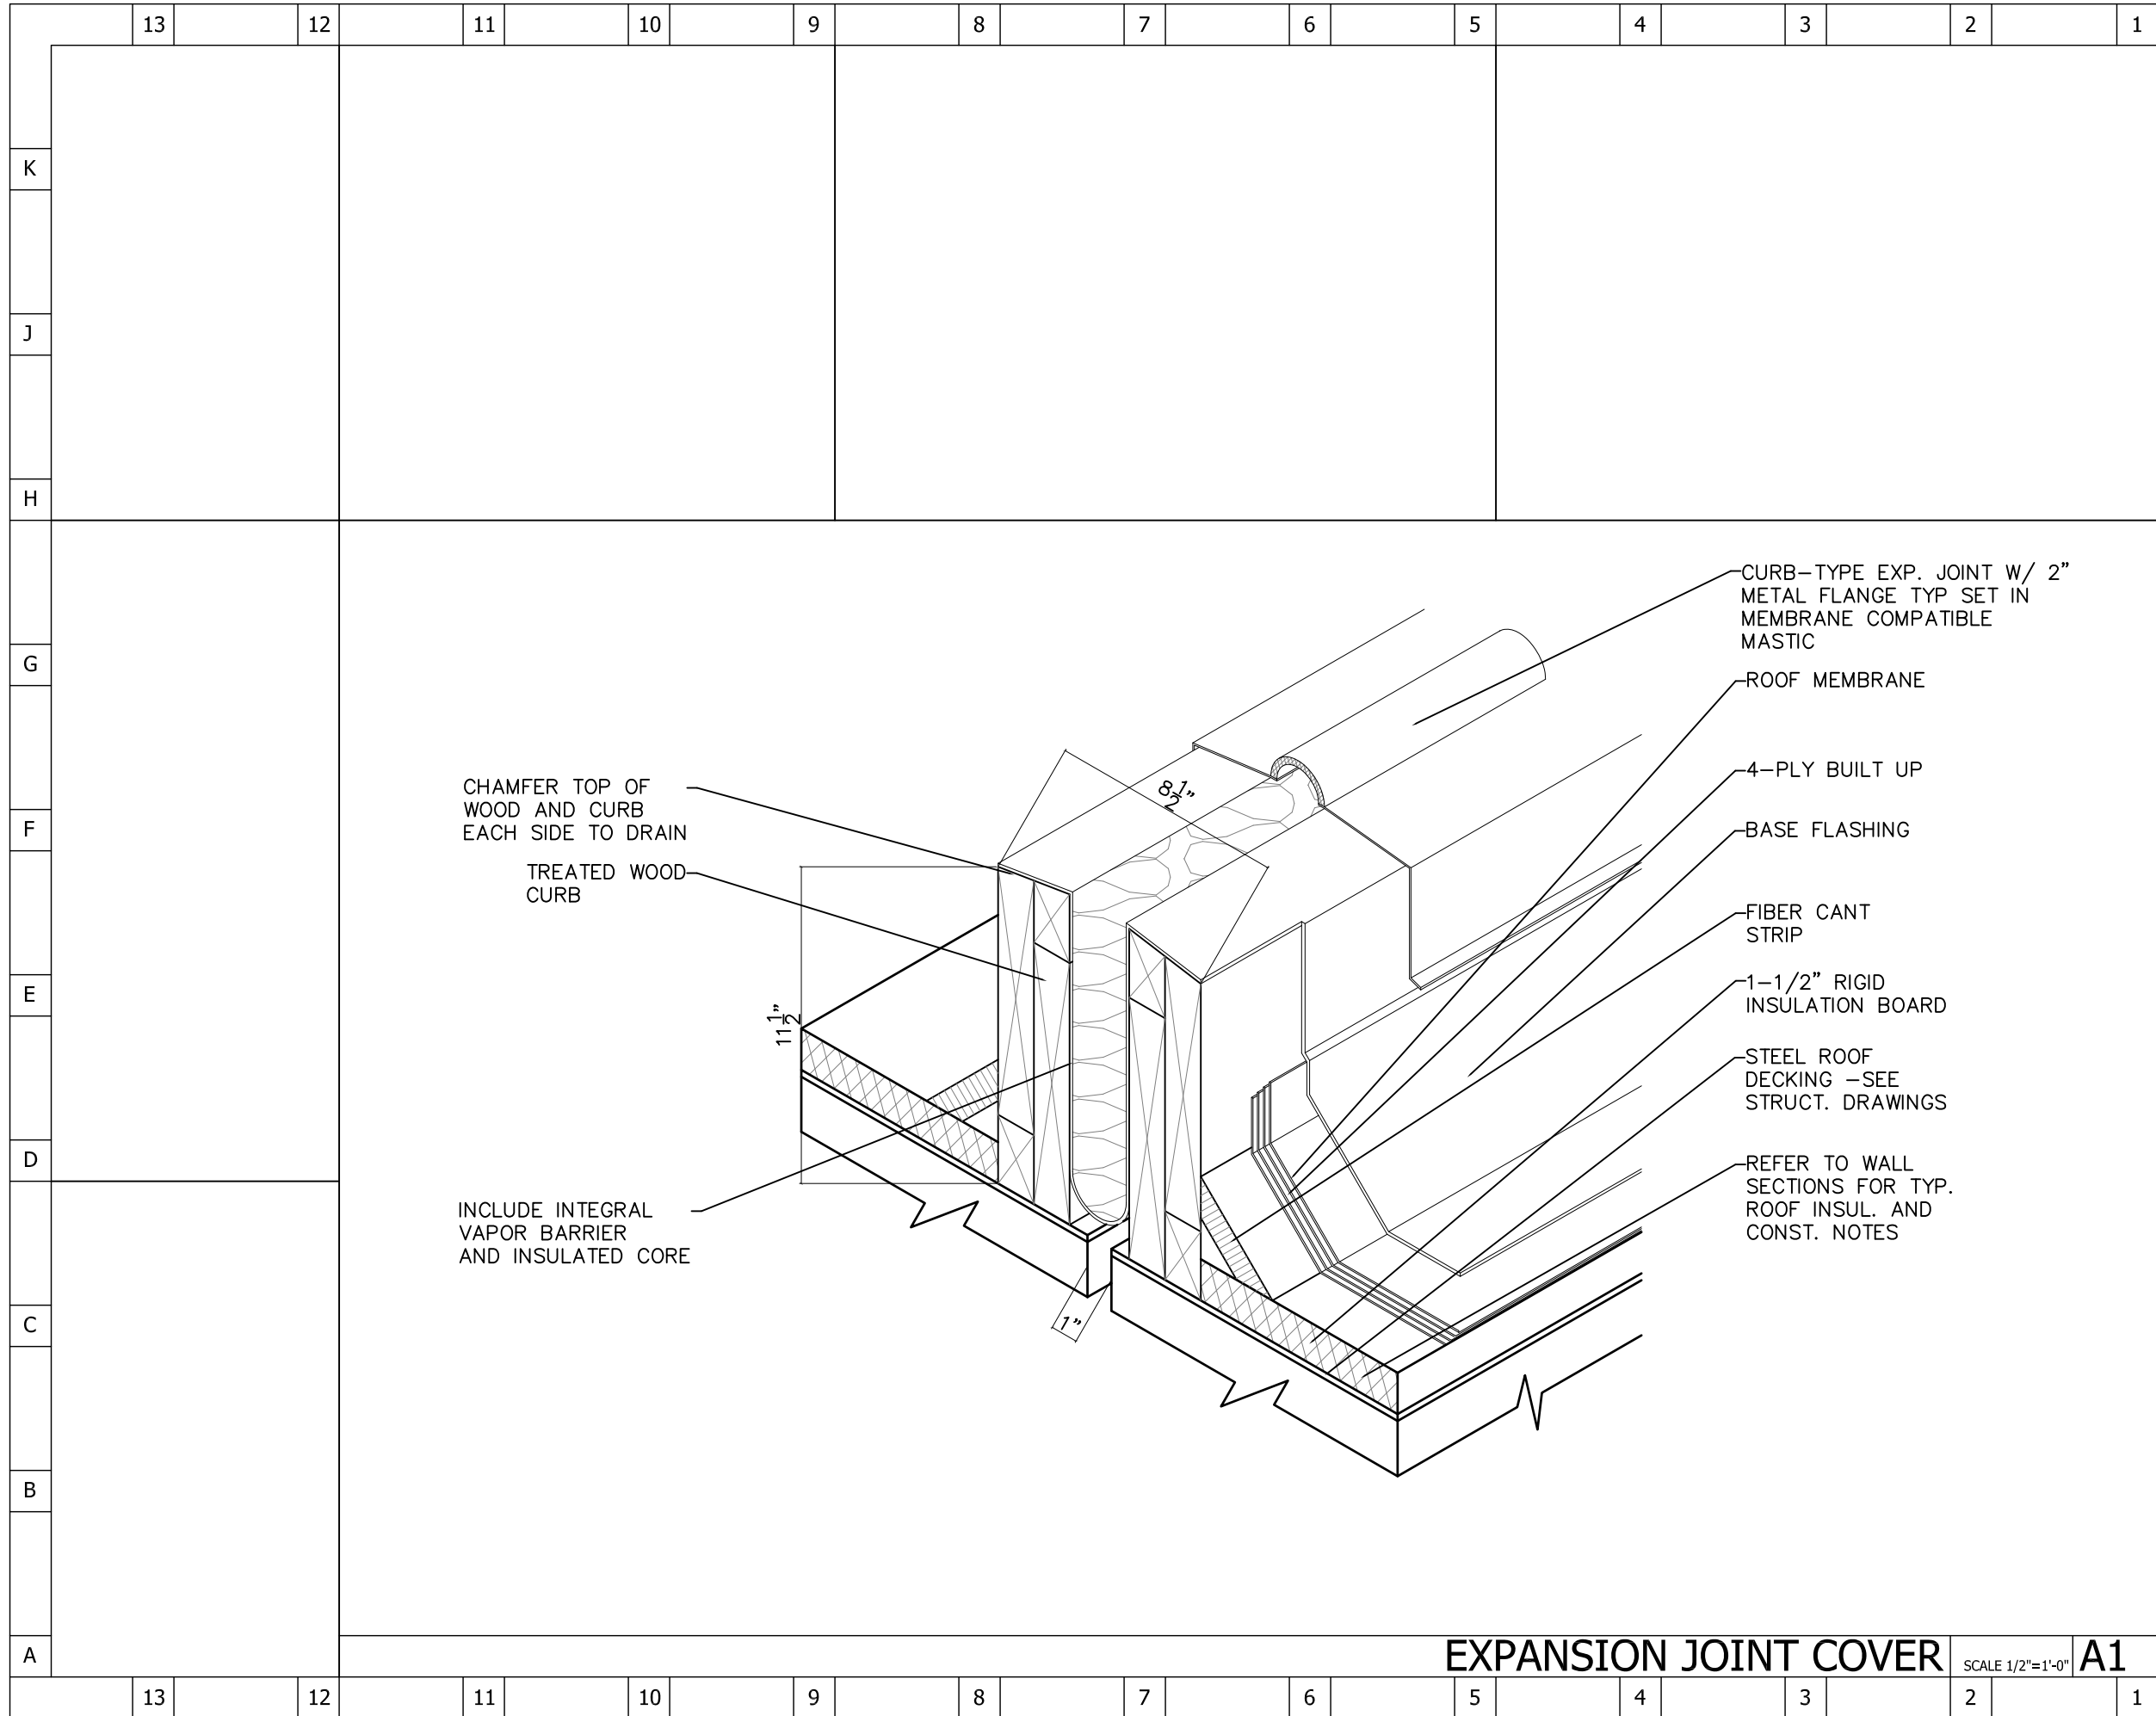

**ARCHITECTURAL & MANUFACTURING SCIENCES**

1906 COLLEGE HEIGHTS BLVD 51066  
BOWLING GREEN, KY 42101-1066  
PHONE: (270) 745-3251

*Established 1920*  
*Excellence in Teaching, Research, and Service*

DO NOT SCALE DRAWINGS. DIMENSIONS AND NOTES TAKE PRECEDENCE. DRAWINGS WITHOUT A SIGNATURE AND SEAL ARE NOT INTENDED FOR CONSTRUCTION.

Not for Construction   
Released for Construction   
Record Drawing

PROJECT TITLE:  
**Expansion Joint Cover**

PROJECT LOCATION:

DRAWING REVISIONS

#	DATE:	DESCRIPTION
1		
2		

JOB NUMBER

DRAWN BY:  
Kevin Barthlow


CHECKED BY:

CLASS:  
AMS 373


DATE:

SCALE:


**EXPANSION JOINT COVER** SCALE 1/2"=1'-0" **A1**

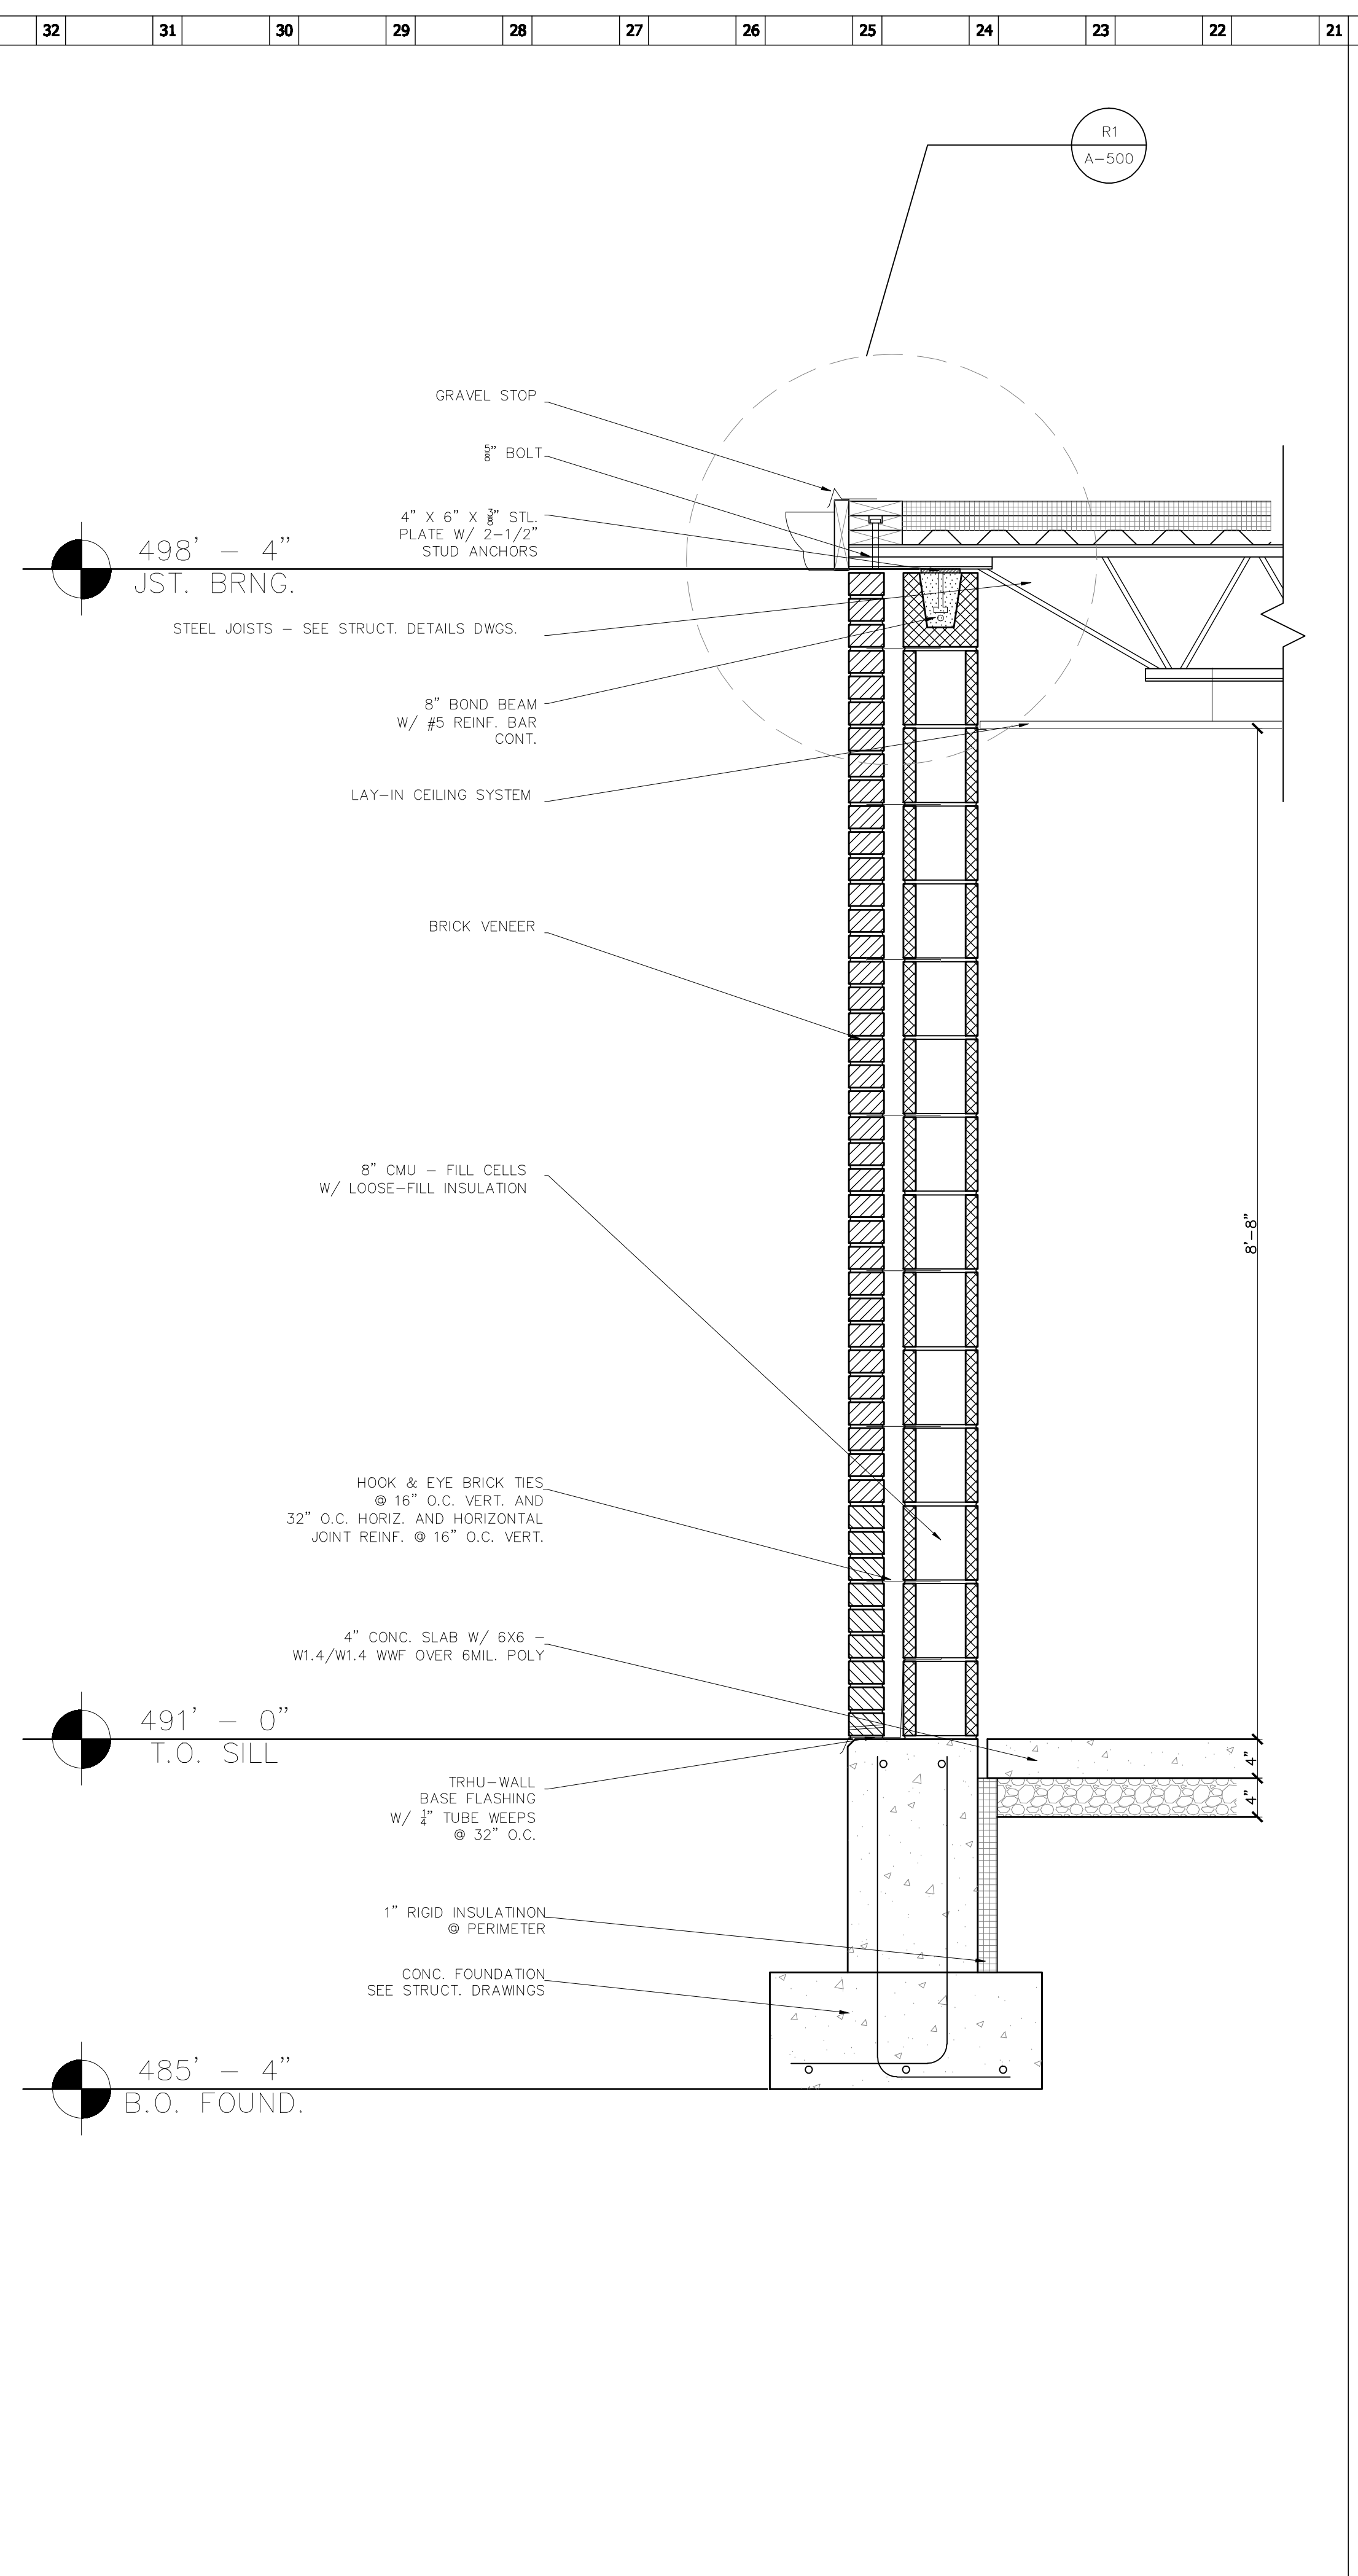


**WALL SECTION W/O WINDOW** SCALE 1/4"=1'-0" **A21**

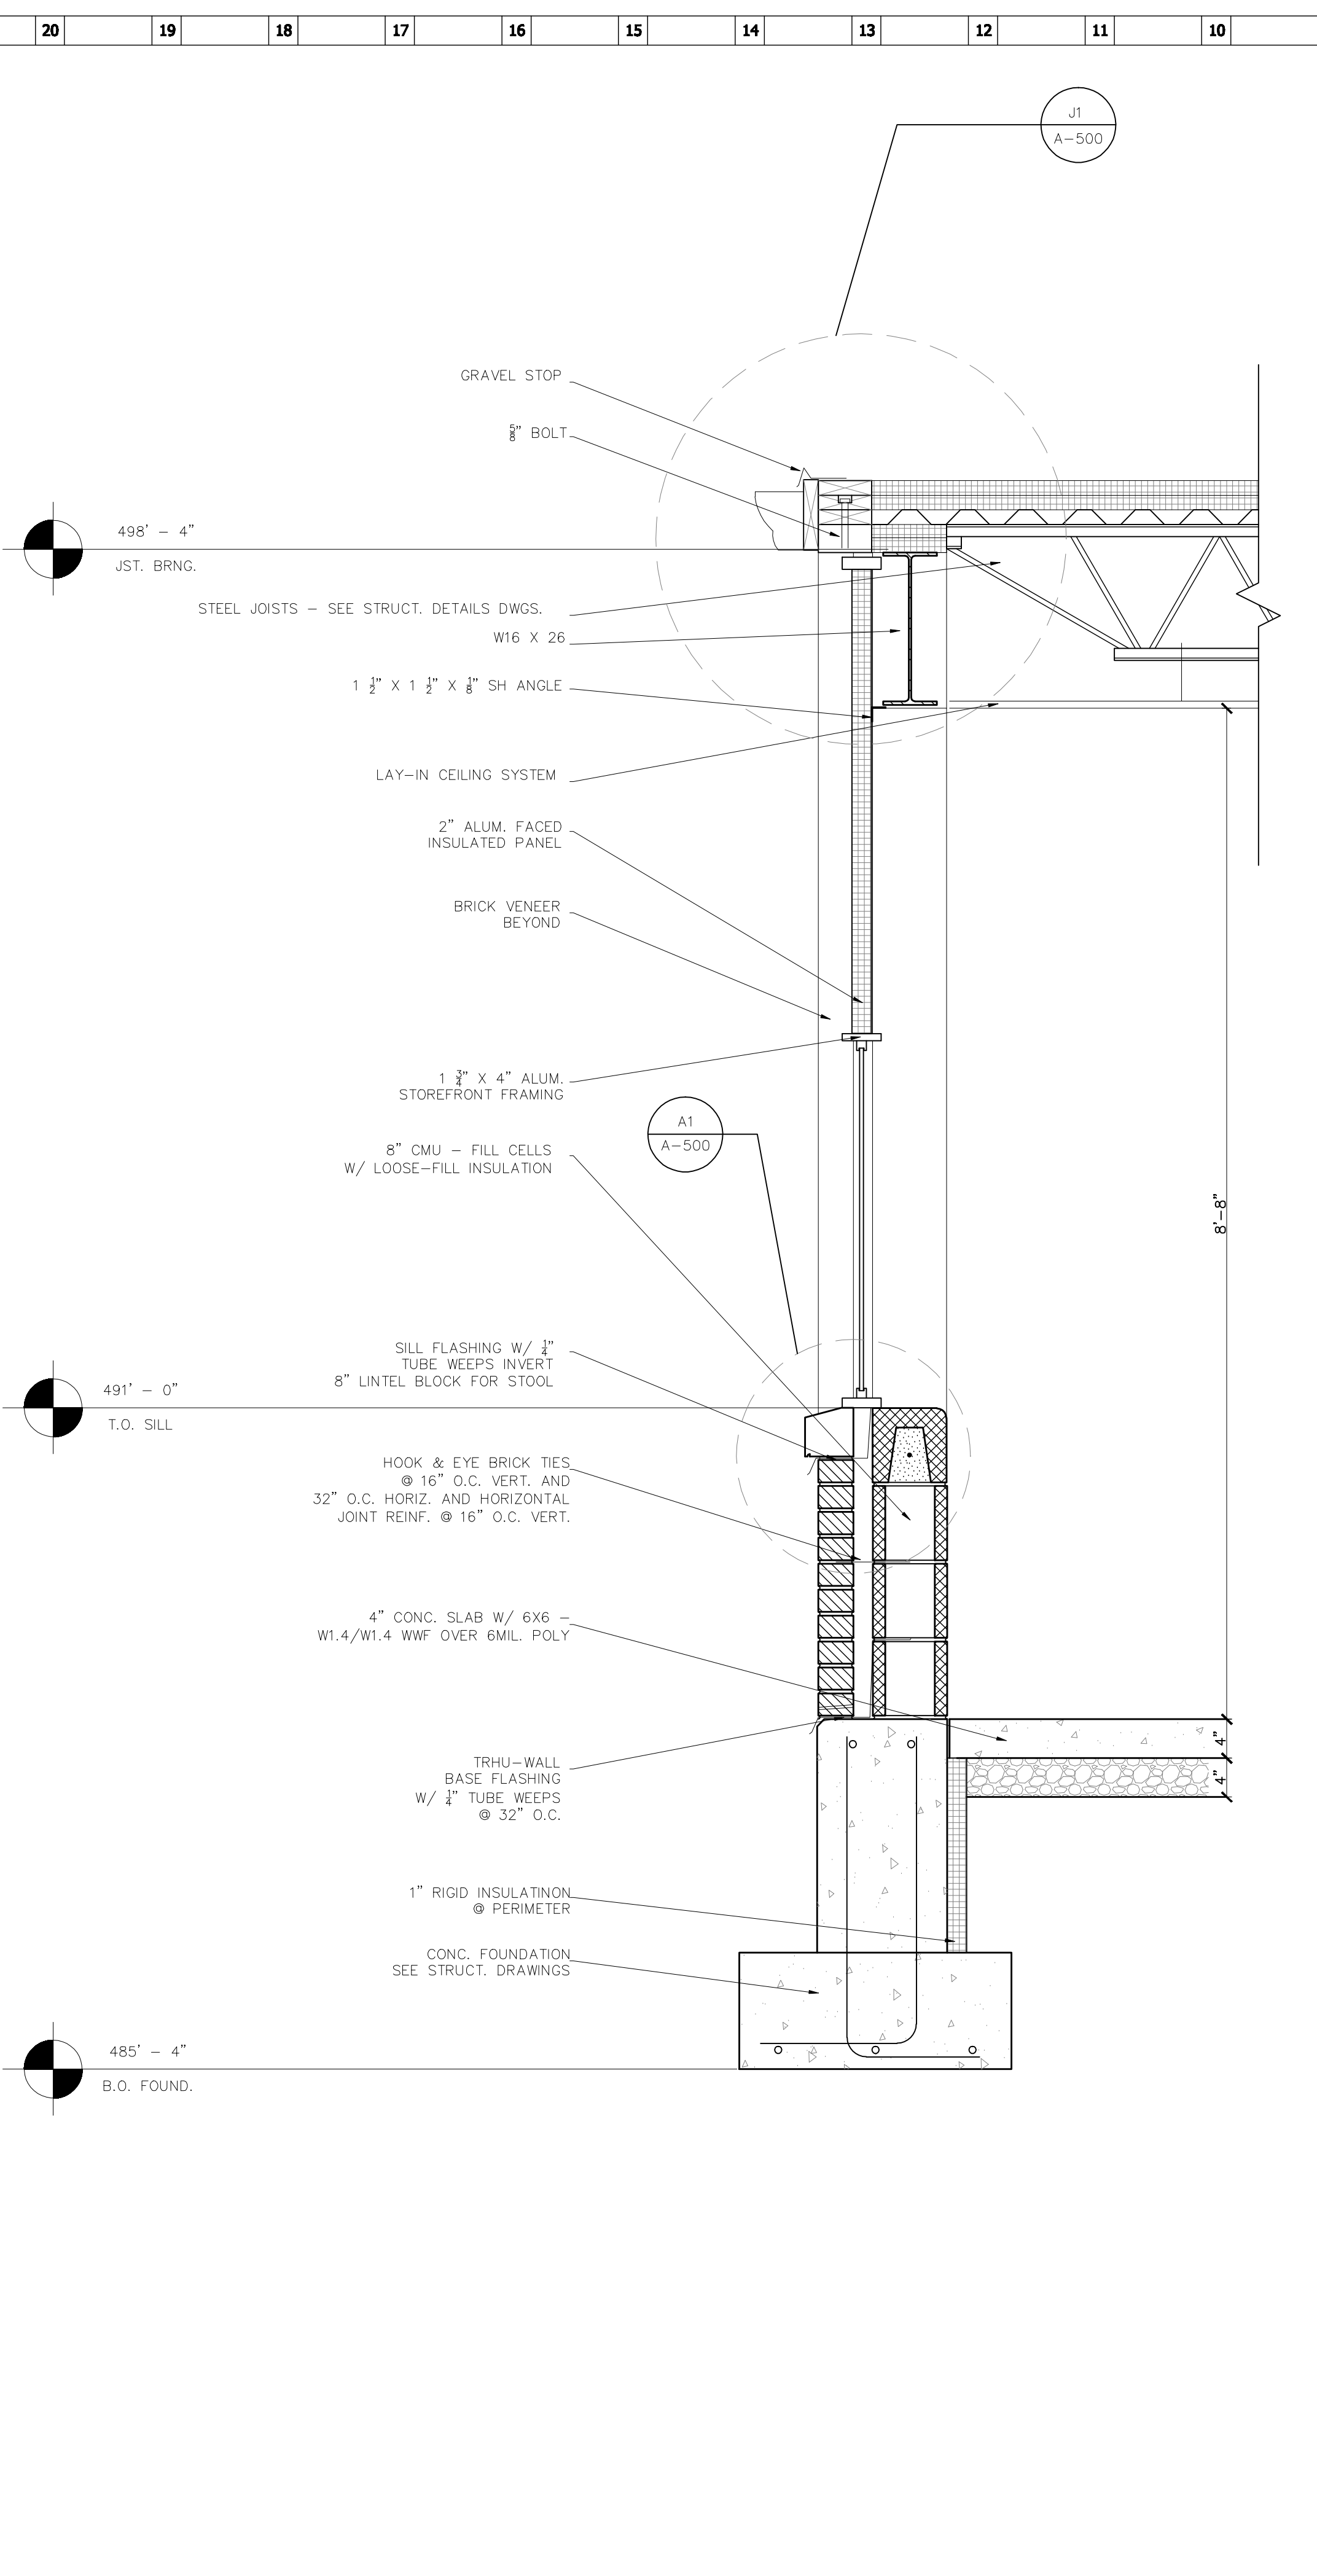


**WALL SECTION W/ WINDOW** SCALE 1/4"=1'-0" **A9**

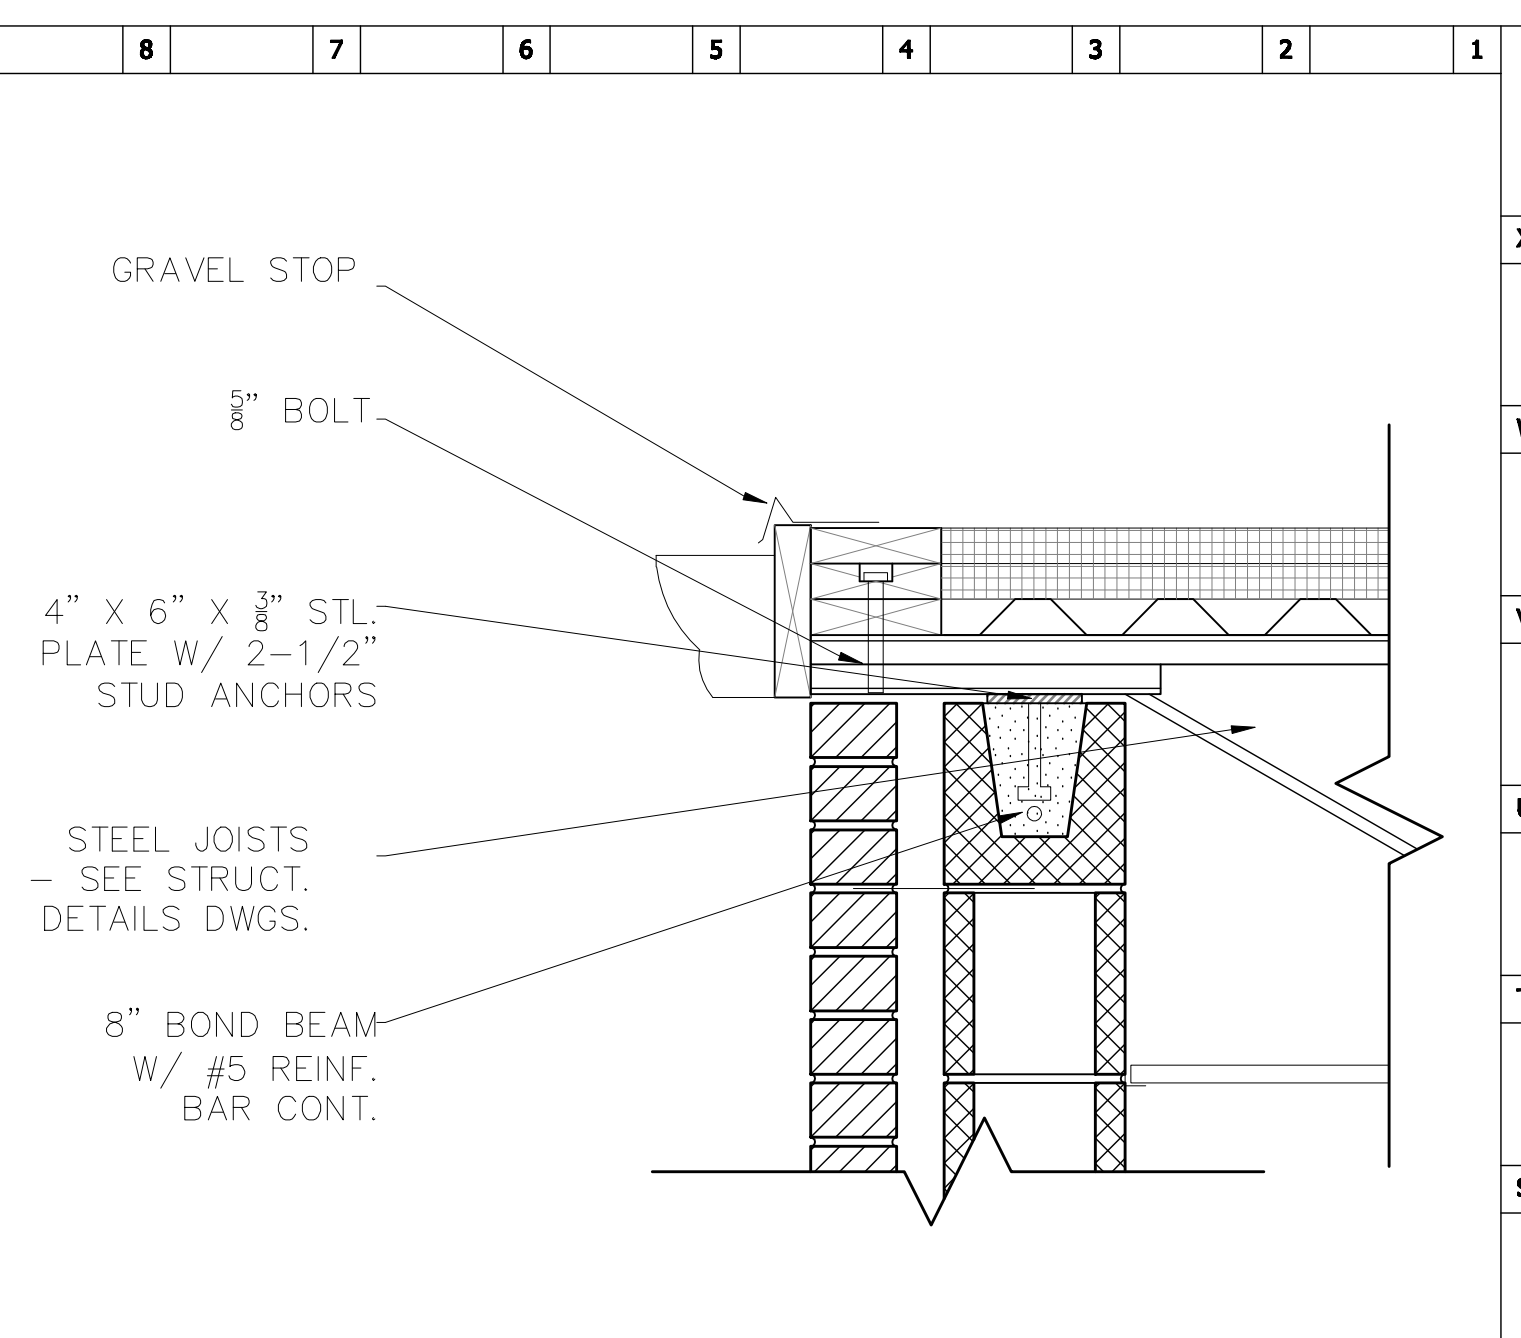

**SOFFIT W/O WINDOW DETAIL** SCALE 1/2"=1'-0" **R1**

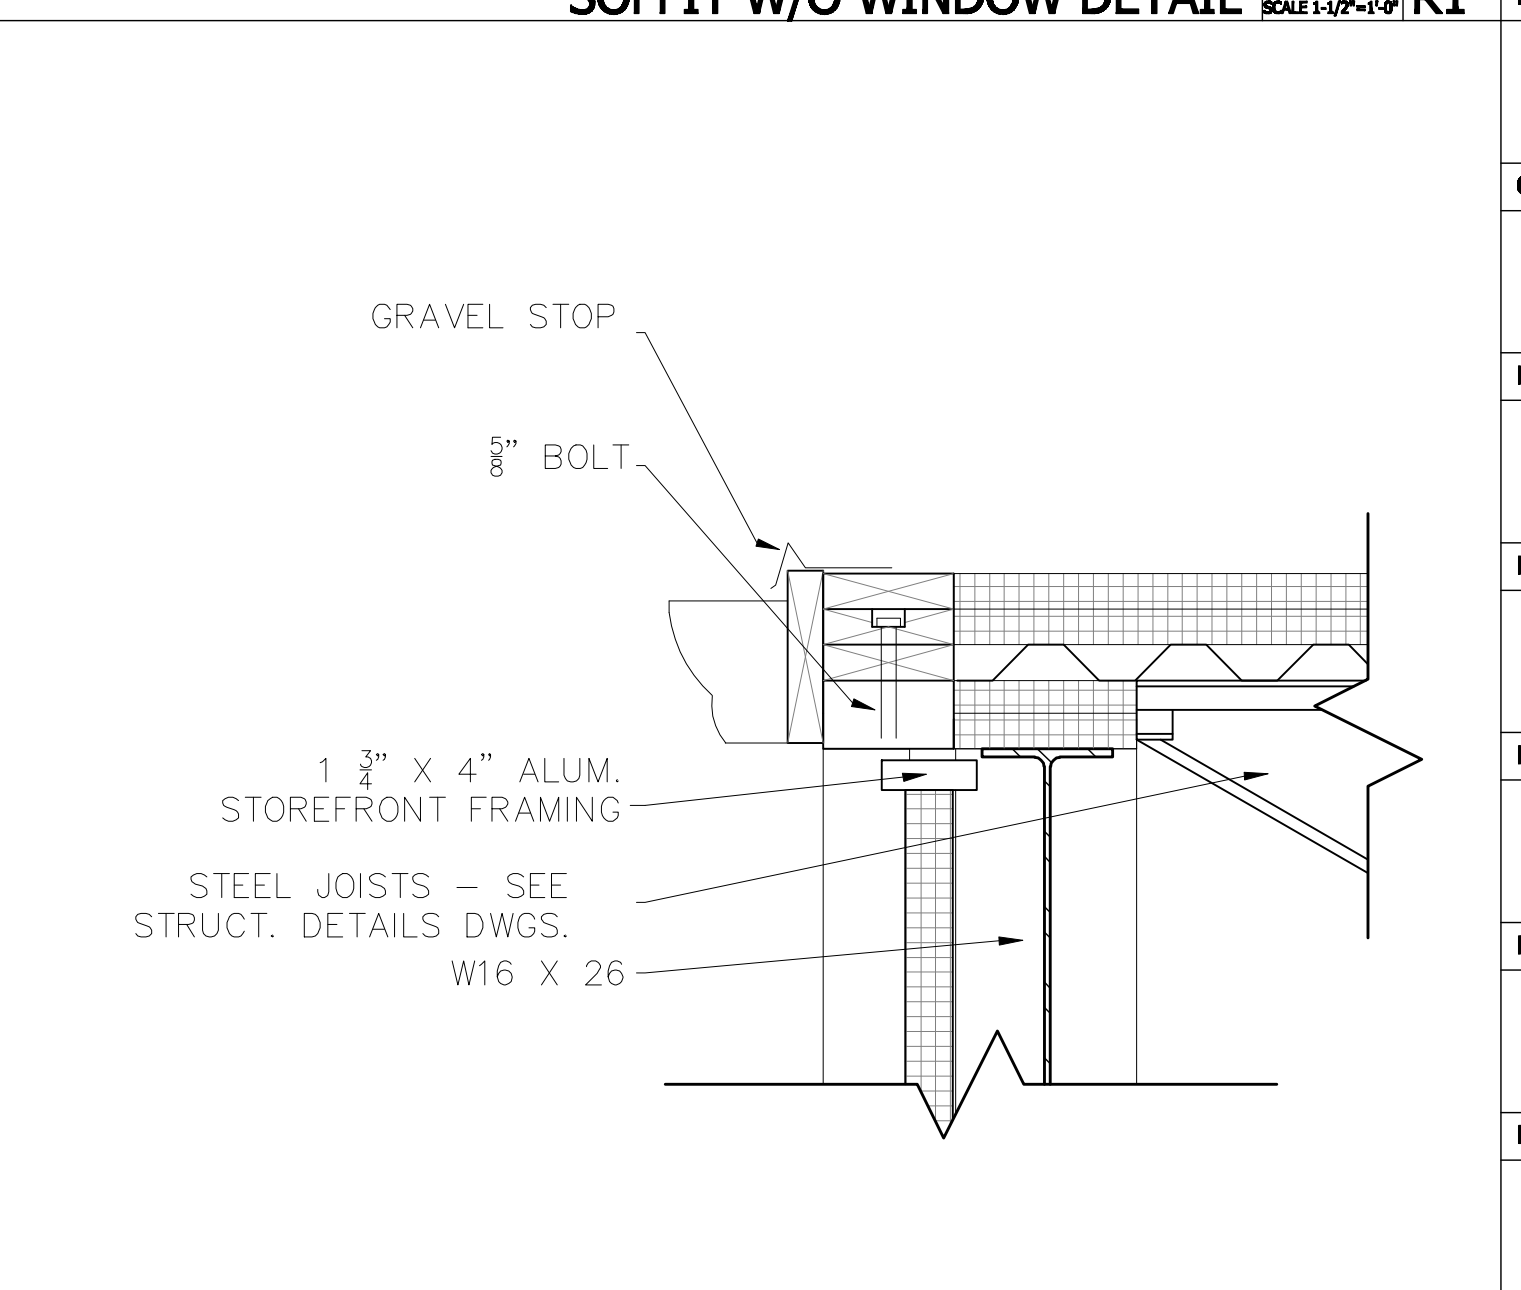

**SOFFIT W/ WINDOW DETAIL** SCALE 1/2"=1'-0" **J1**

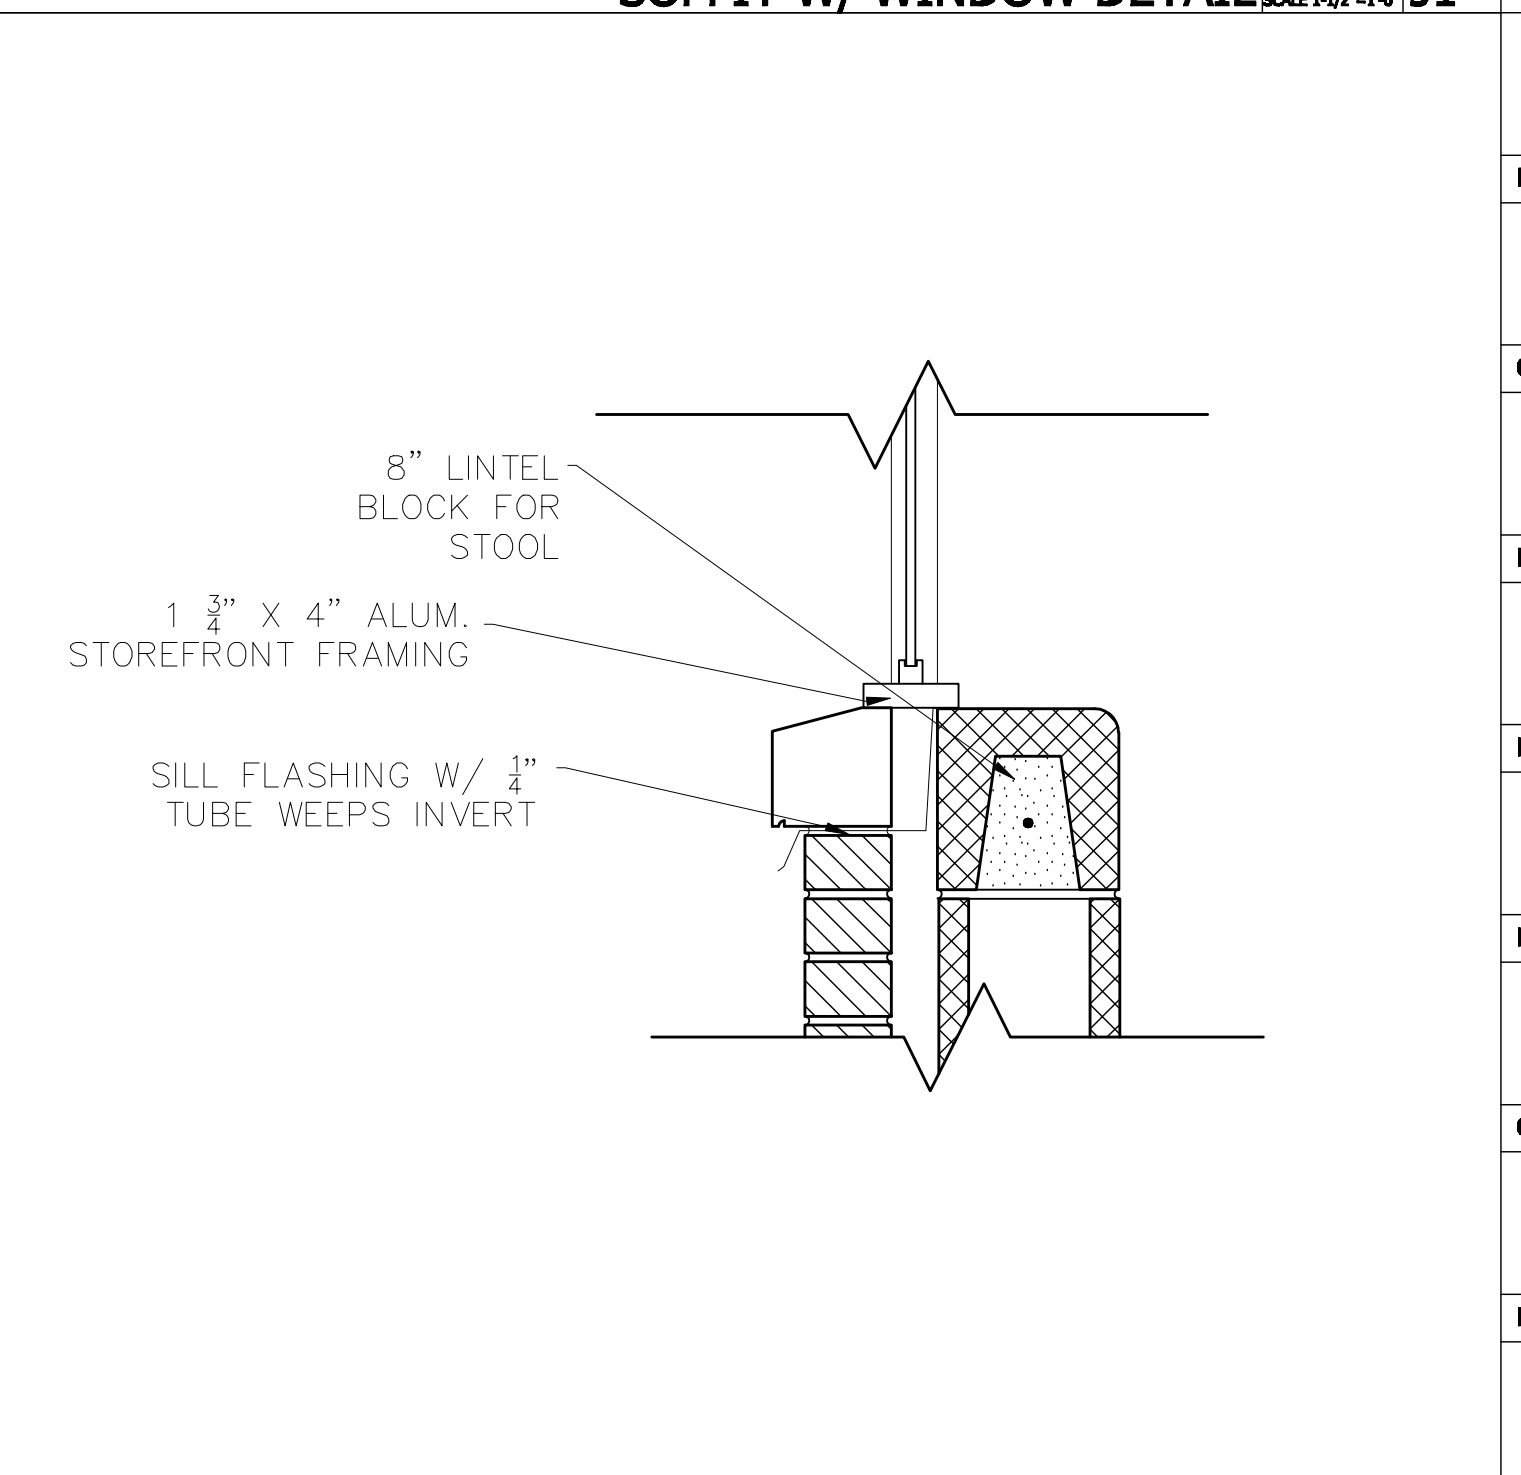

**WINDOW SILL DETAIL** SCALE 1/2"=1'-0" **A1**

DO NOT SCALE DRAWINGS. DIMENSIONS AND NOTES TAKE PRECEDENCE. DRAWINGS WITHOUT A SIGNATURE AND SEAL ARE NOT INTENDED FOR CONSTRUCTION.

- Not for Construction
- Released for Construction
- Record Drawing

PROJECT TITLE:  
**SCHOOL DETAIL 1**

PROJECT LOCATION:

DRAWING REVISIONS	REVISION DESCRIPTION	DATE	BY	CHKD	APP'D
1					
2					
3					
4					
5					
6					

JOB NUMBER

DRAWN BY:  
**KEVIN BARTHLOW**

CHECKED BY:

CLASS:  
**AMS 373**

DATE:

SCALE: